

PROPOSED LAND DEVELOPMENT & CONDITIONAL USE PLAN RON LEWIS SERVICE ADDITION

CRANBERRY TOWNSHIP
BUTLER COUNTY, PENNSYLVANIA

OWNER:

BARRON AGENCY INC.
20839 ROUTE 19
CRANBERRY TWP., PA 16066

LANDSCAPE ARCHITECT:

VICTOR-WETZEL ASSOCIATES
409 BRIGAD STREET
SUITE 270
SEWICKLEY, PA 15143
PHONE: (412) 741-2290



SURVEYOR/ENGINEER:


THE GATEWAY ENGINEERS
201 MAIN STREET
BUTLER, PA 16001

DRAWING SCHEDULE

1001 SITE OVER SHEET
1002 SITE SURVEY CONTOUR SHEET
1003 CIVIL FINAL SITE PLAN
1004 CIVIL FINAL CONCRETE PLAN
1005 CIVIL FINAL UTILITY PLAN
1006 CIVIL FINAL LIGHTING PLAN
1007 CIVIL FINAL GRADE/PAVEMENT PLAN
1008 CIVIL FINAL DRAINAGE/STORMWATER PLAN
1009 CIVIL FINAL EROSION CONTROL/SEDIMENTATION PLAN
1010 CIVIL FINAL PROPOSED
1011 CIVIL FINAL CONSTRUCTION DETAILS
1012 CIVIL FINAL TRUCK/LOADING PLAN
1013 CIVIL FINAL WAREHOUSE/BLACK TOP/CONCRETE PLAN
1014 CIVIL FINAL CONSTRUCTION TIME/HAZARD WAREHOUSE PLAN
1015 CIVIL FINAL FINAL CONSTRUCTION/STORMWATER/HAZARD WAREHOUSE PLAN
1016 CIVIL FINAL FINAL CONSTRUCTION/STORMWATER/HAZARD WAREHOUSE PLAN
1017 CIVIL FINAL FINAL CONSTRUCTION/STORMWATER/HAZARD WAREHOUSE PLAN
1018 CIVIL FINAL FINAL CONSTRUCTION/STORMWATER/HAZARD WAREHOUSE PLAN




LOCATION MAP
SCALE: 1" = 600'

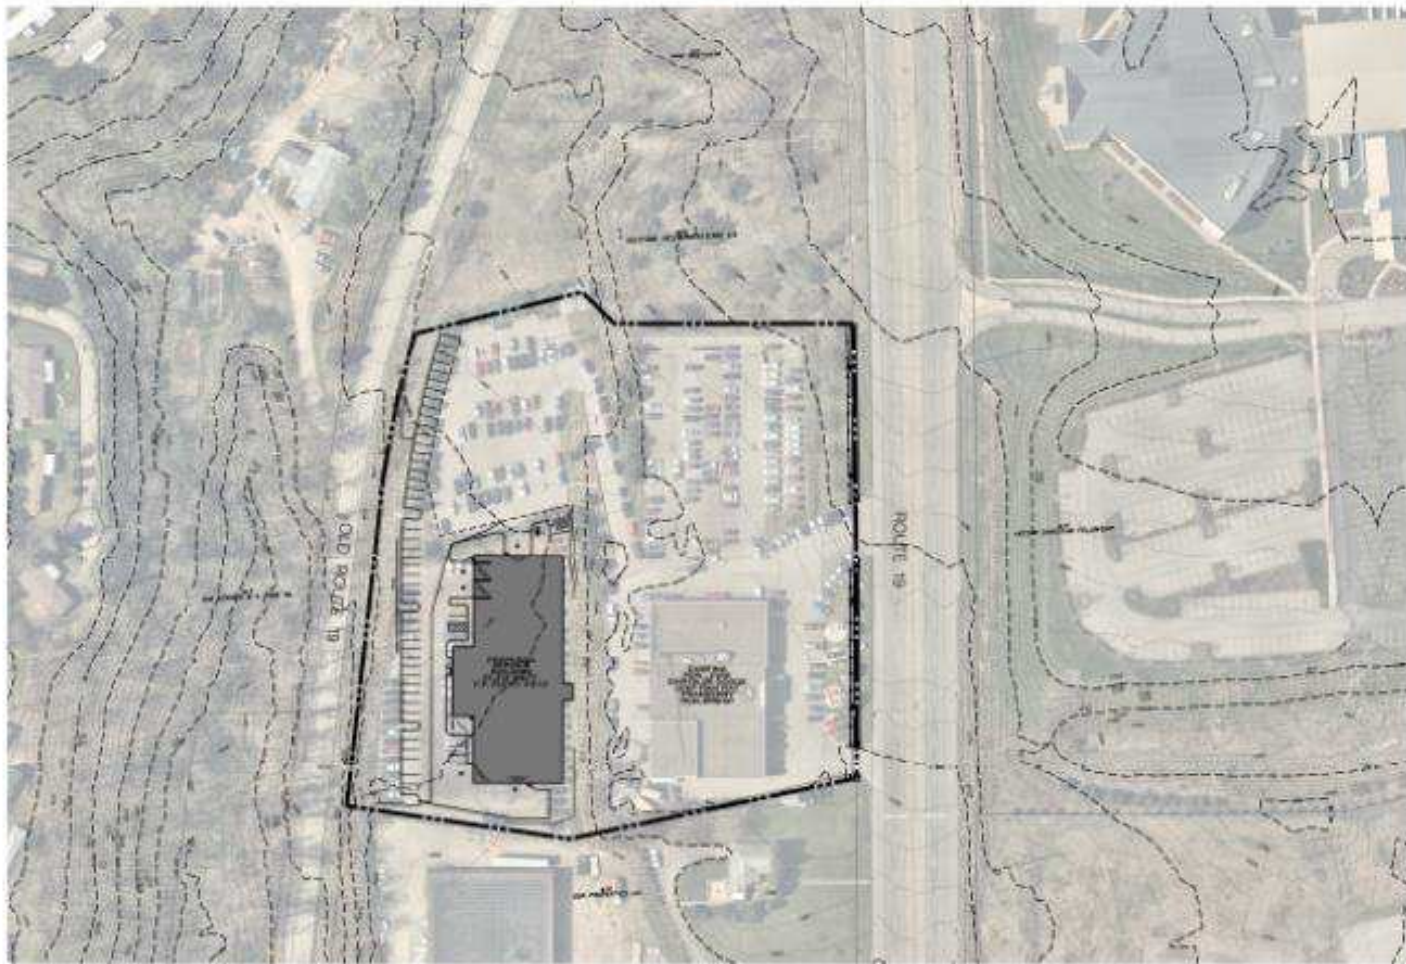

SITE PLAN

SCALE: 1" = 60'

DATE: AUGUST 7, 2018
REV: SEPT. 7, 2018

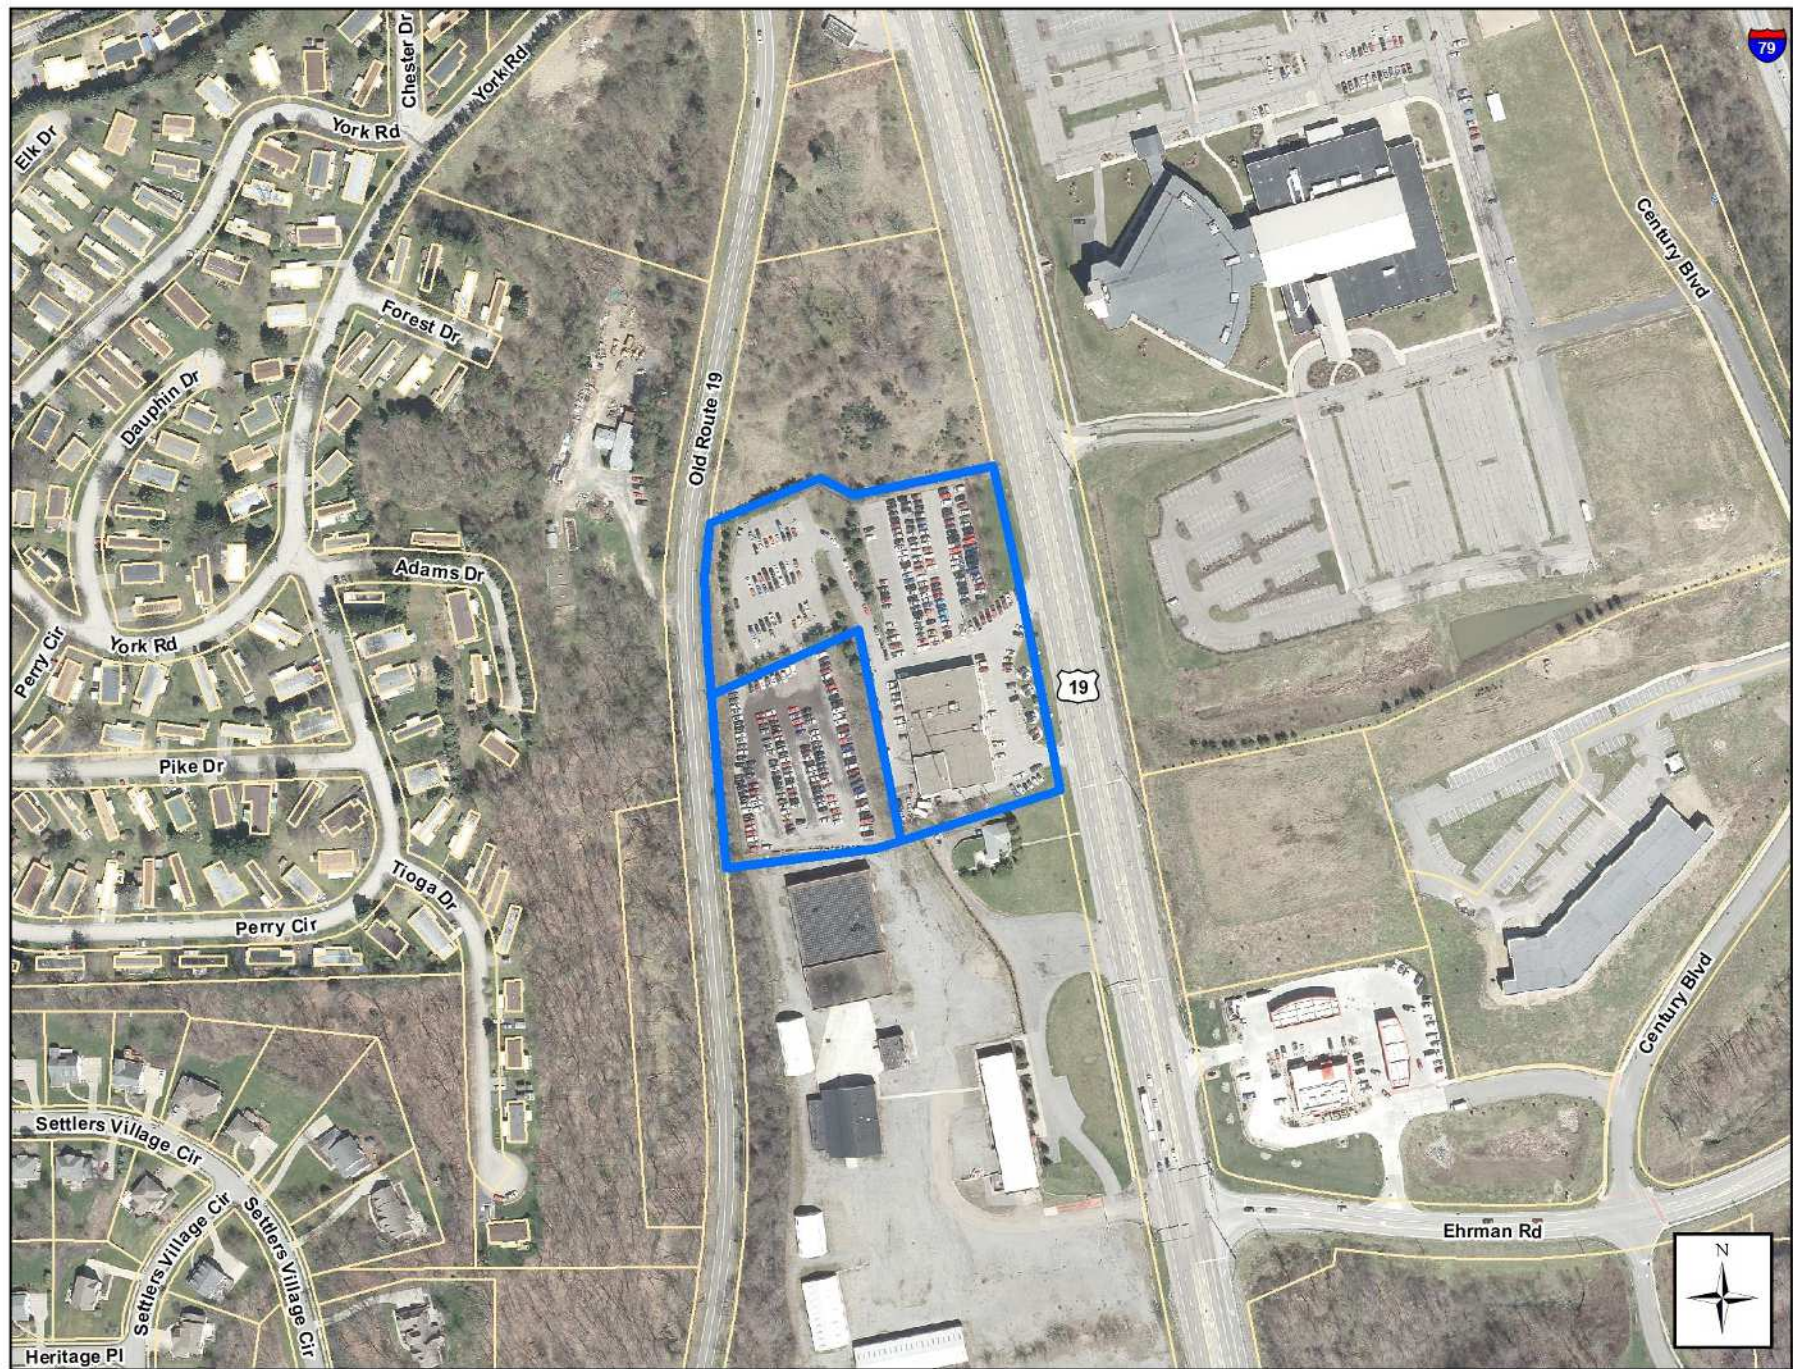

1. ZONING DISTRICT: PIC DISTRICT

3. PROPOSED USE: AUTOMOTIVE SERVICE (CONDITIONAL USE)

4. PROPOSED BUILDINGS: PROPOSED SERVICE BUILDING 21,310 SQ.FT.

5. A 20' UTILITY EASEMENT SHALL BE PROVIDED FOR ALL UTILITIES.

E. ALL UTILITIES TO BE UNDERGROUND.

7. AS PER THE APPROVED STORM WATER MANAGEMENT PLAN THE TOWNSHIP SHALL HAVE RIGHT OF ACCESS TO THE FACILITY FOR THE PURPOSES OF MAINTENANCE IN THE EVENT THE OTHER AGENCIES OR HEIRS DO NOT DESIGNATE MAINTAIN THE FACILITY. THE TOWNSHIP RESERVES THE RIGHT OF ACCESS FOR TOWNSHIP FOR ALL COSTS ASSOCIATED WITH SAID MAINTENANCE. THE AFORESAIDED RIGHT OF ACCESS TO THE TOWNSHIP OR TO MAINTAINING THE RESPONSIBILITY OF THE TOWNSHIP OF THE SAID MAINTENANCE WORK SHALL BE ASSIGNED TO THE TOWNSHIP ASSOCIATED WITH REQUIRED ACCESS FOR MAINTENANCE PURPOSES.

YARD REQUIREMENTS

	REQUIRED	PROPOSED
MINIMUM LOT AREA	1 ACRE	0.375 ACRES
MINIMUM FRONT YARD	25 FEET	88 FEET
MINIMUM SIDE YARD	5 FEET	45 FEET
MINIMUM REAR YARD	58 FEET	N/A FEET
MINIMUM PERVIOUS AREA	485 SQ. FT. MIN	265 SQ. FT. MIN
BUILDING HEIGHT MAXIMUM	50'	27'-4"
INTERNAL GREENSPACE	125 MINIMUM	11.0%

P&H INC.


1. TOTAL BUILDING SQUARE FEET = 21,314 SF.
VEHICLE SALES, RENTAL, AND SERVICE = 1 PER 700 SQ. FT. SPA. PLUS 1 PER EACH
AND OTHER SPACE TO BE USED BY CUSTOMERS
2. TOTAL PARKING REQUIRED =
SERVICE BUILDING: 21,314 SF. / 700 = 30 SPACES
2,500 SQ. FT. / 500 = 5 PARKING SPACES
34 PARKING SPACES (INCLUDE 2 ADA SPACES)
3. TOTAL PARKING REQUIRED = 34 PARKING SPACES REQUIRED
4. TOTAL PARKING SPACES PROPOSED 34 NEW PARKING SPACES

PROPOSED WINNERS

- [illegible]

DETAIL REFERENCES

- | | |
|--|-------------------------------|
| 7) HANDICAP SIGN | 31) PAVING NOTCH- DETAIL |
| 8) CURB CUT RAMP | 32) WALKWAY MATERIAL |
| 9) 10-19 TYPICAL SIDEWALK (WIDTH AS NOTED) | 33) RESTRICTED ACCESS SIGNAGE |
| 10) PROPOSED STAMPED CONCRETE CROSSWALK | 34) HEAVY-DUTY CONCRETE |
| 11) BRICK PIER & FENCING | 35) DUMPSTER ENCLOSURE |
| 12) TOWNSHIP TRIM | 36) PROPOSED ASPHALT PAVING |
| 13) TOWNSHIP BENCH | |

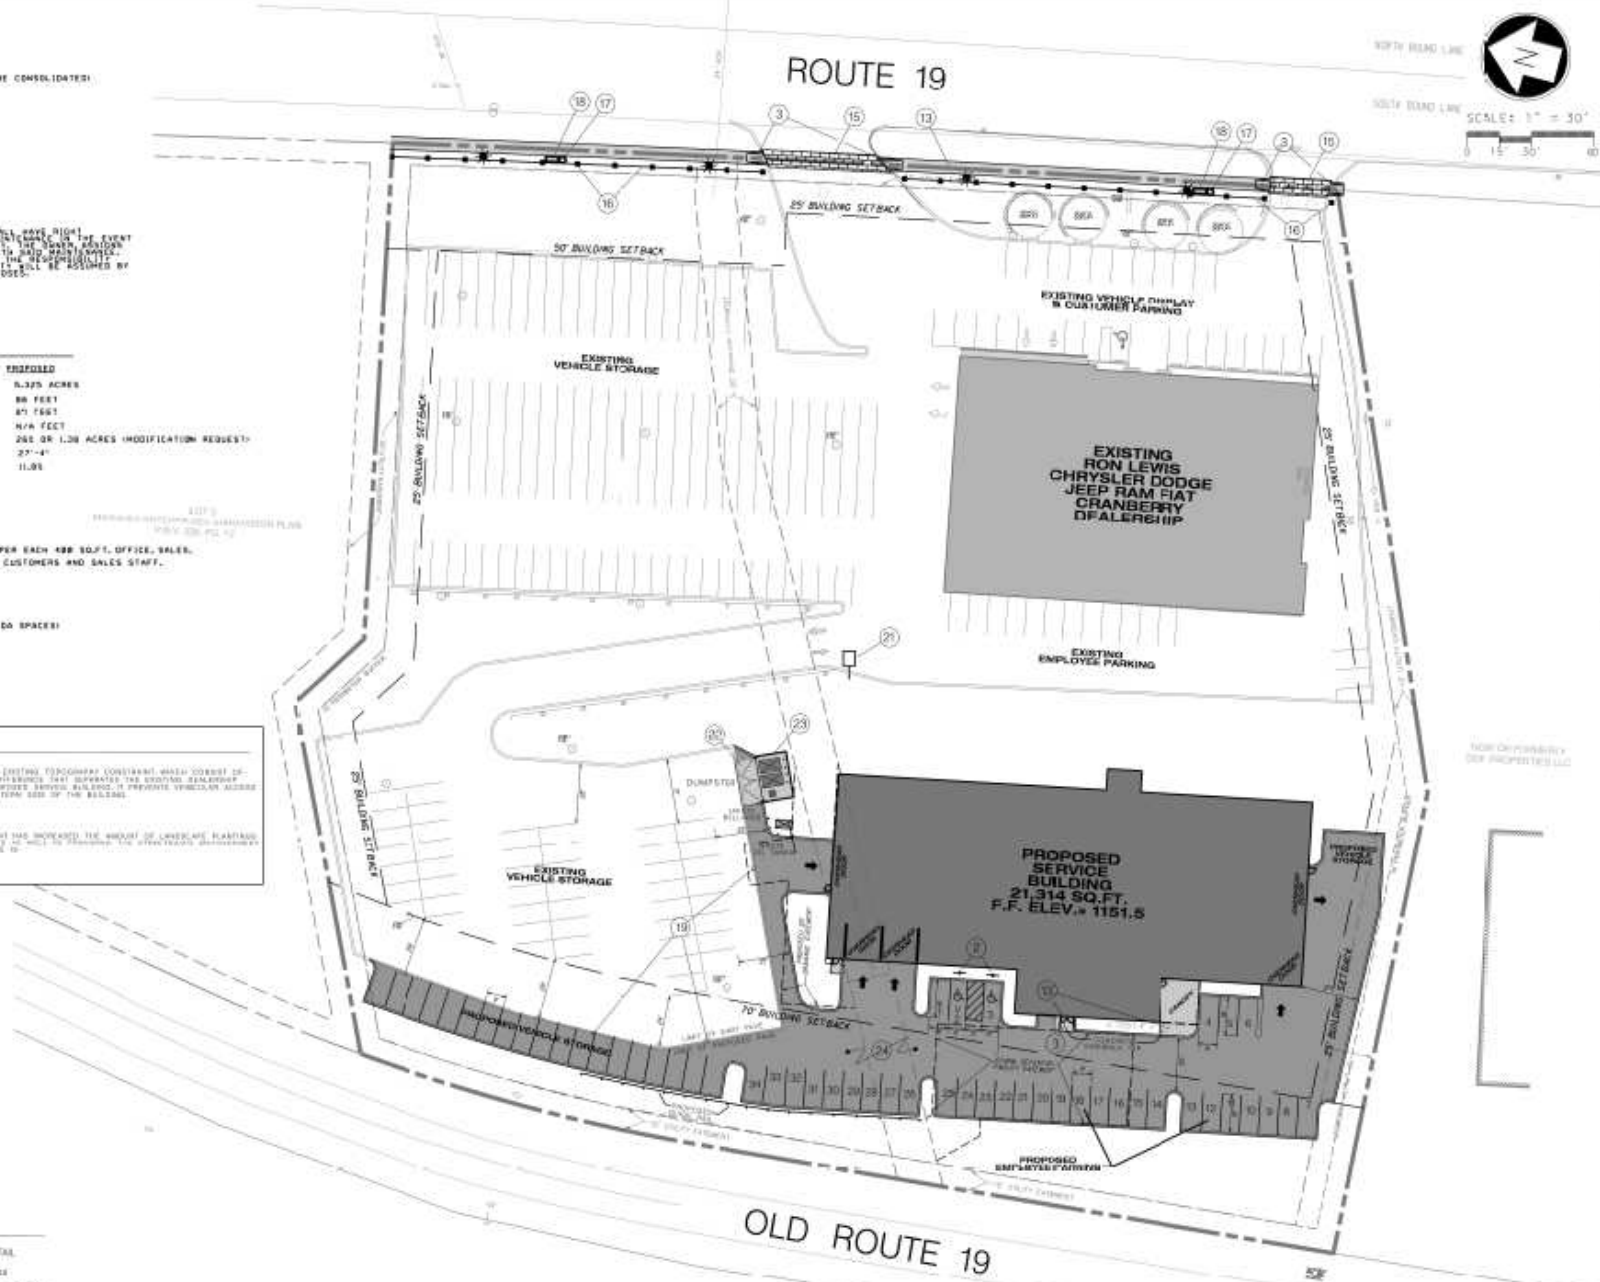[illegible]

For a full discussion, please see
 1001 1st St., Suite 100
 San Francisco, CA 94104
 Tel: 415-398-1000
 Fax: 415-398-1001
 Web: www.1001.com


Page _____
 of _____
 Date _____

IRON LEWIS SERVICE ADDITION
 10000 HWY 107 BOX 4P BUTLER COUNTY, PA
 REQUEST FOR
 BIDDING SERVICE INC
 7020 WILSON RD
 224-9622013 PA 15006

SITE PLAN
C-100

ISSN: 1744-3758
DOI: 10.1002/eqm2.1200
© 2019 John Wiley & Sons, Ltd.

Date: AUGUST 1, 2018
Lab Number: C-000003
Client No: .

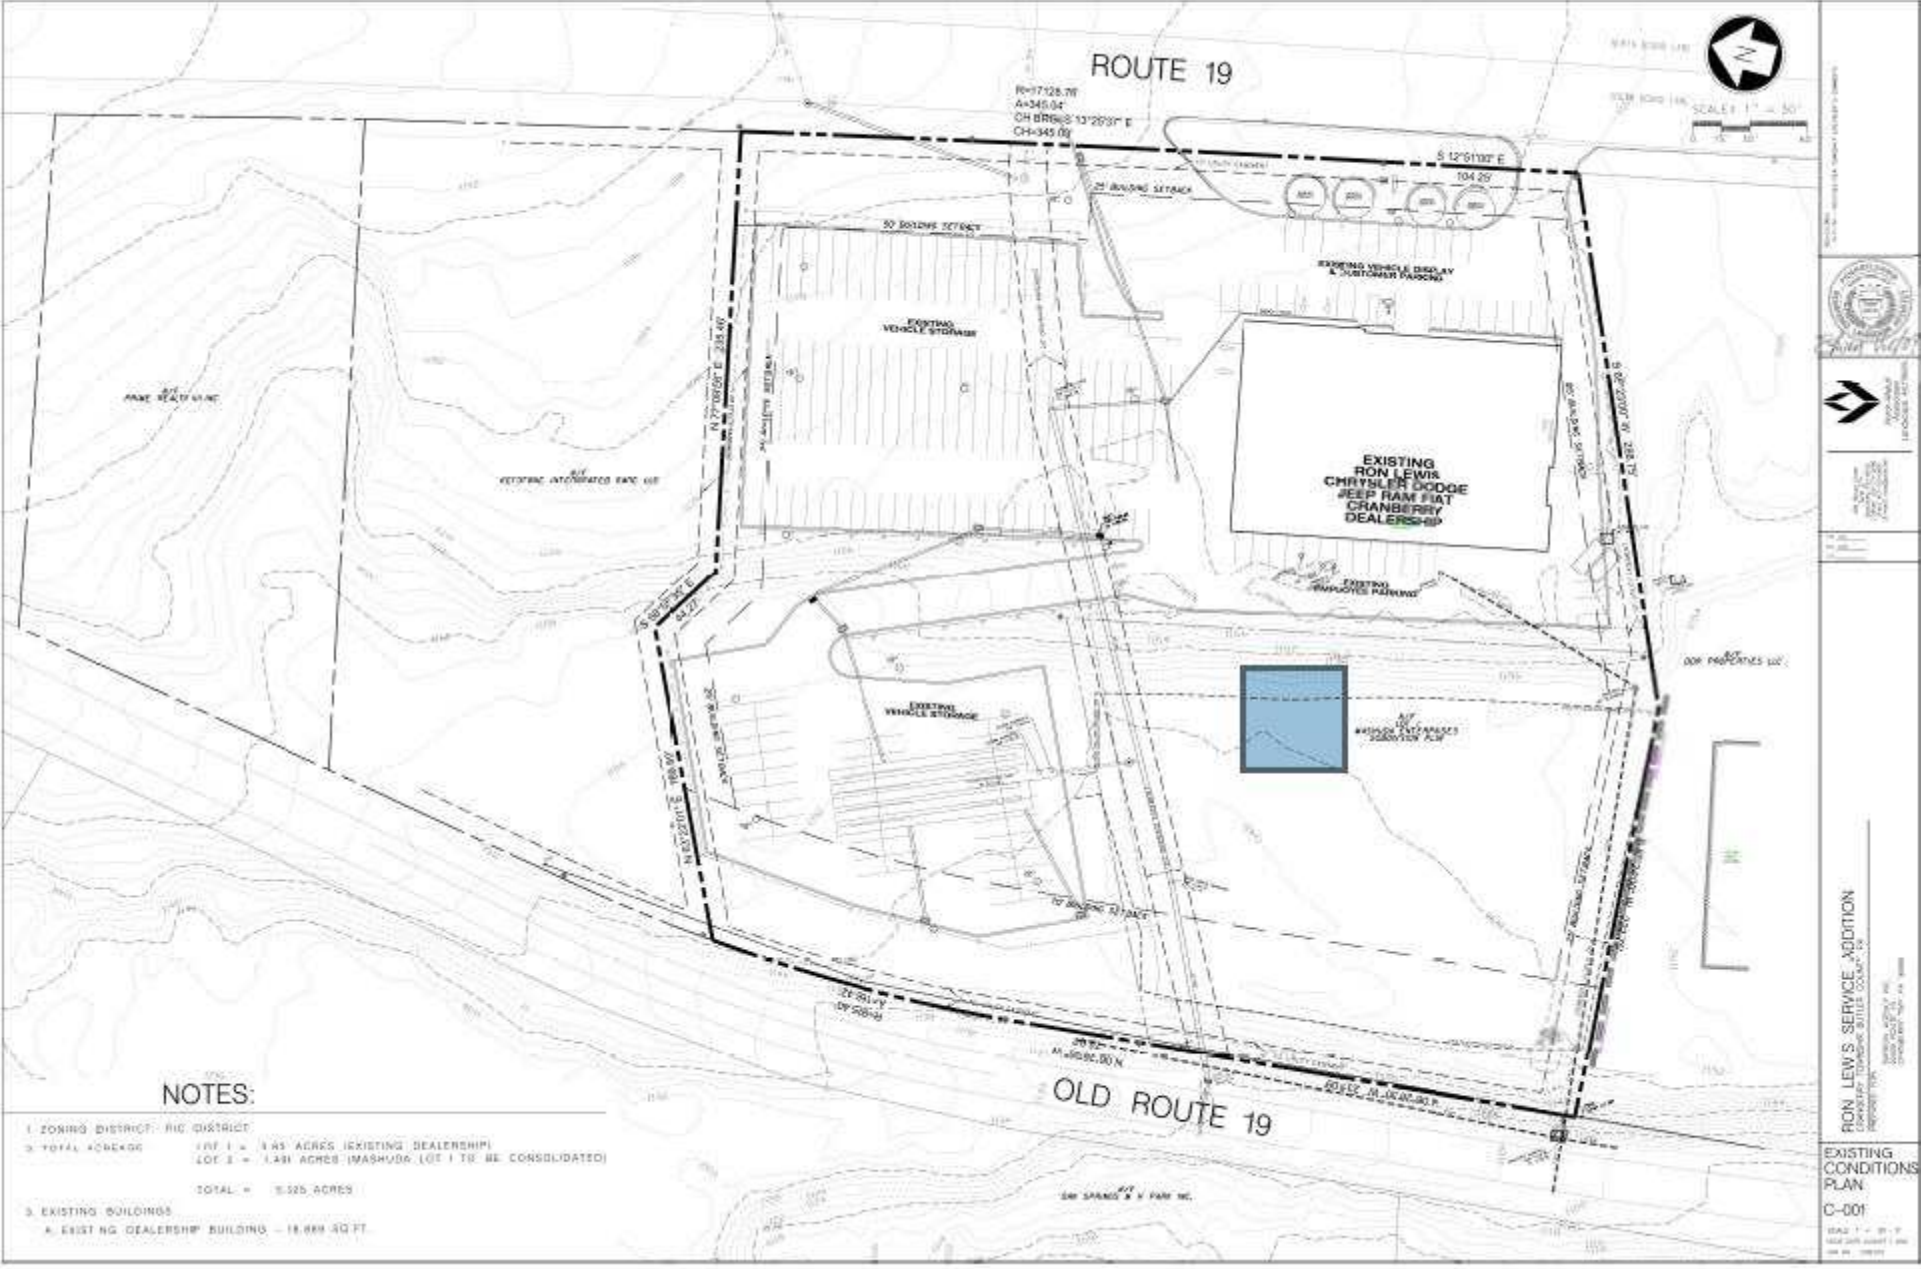

NOTES:

- 1. ZONING DISTRICT: RUC DISTRICT
- 2. TOTAL ACRES: LOT 1 = 1.45 ACRES (EXISTING DEALERSHIP) LOT 2 = 1.431 ACRES (MASHUDA LOT 1 TO BE CONSOLIDATED) TOTAL = 2.881 ACRES
- 3. EXISTING BUILDINGS: A. EXISTING DEALERSHIP BUILDING - 18,889 SQ. FT.

RON LEWIS SERVICE ADDITION
CONCEPT TOWNSHIP BATTLE COUNTRY, IN

EXISTING
CONDITIONS
PLAN
C-001

DATE: 11-11-17
DRAWN BY: J. H. HARRIS
CHECKED BY: J. H. HARRIS



[illegible]

Lot	Qty	Quantity Used	Retention Limit	Use	Remarks
12	14	Calculus (new) (Woods)	Not permitted (Greenwood)	0.00	0.00
Subtotal:					
17	3	Calculus (new)	Not allowed (new)	0.00	0.00
18	4	Calculus (new)	Not allowed	0.00	0.00
19	4	Calculus (new)	Not allowed	0.00	0.00
Subtotal:					
20	10	Calculus (new)	Not allowed (new)	0.00	0.00
21	10	Calculus (new) (Woods)	Not allowed (new)	0.00	0.00
22	10	Calculus (new)	Not allowed (new)	0.00	0.00
23	10	Calculus (new)	Not allowed (new)	0.00	0.00
24	10	Calculus (new)	Not allowed (new)	0.00	0.00

[illegible]

NOTES

	COMPACT CUBIC
	MINI M
	COMPACT CUBIC CUBIC
	MINI M
	COMPACT CUBIC CUBIC
	MINI M
	COMPACT CUBIC CUBIC
	MINI M
	COMPACT CUBIC CUBIC

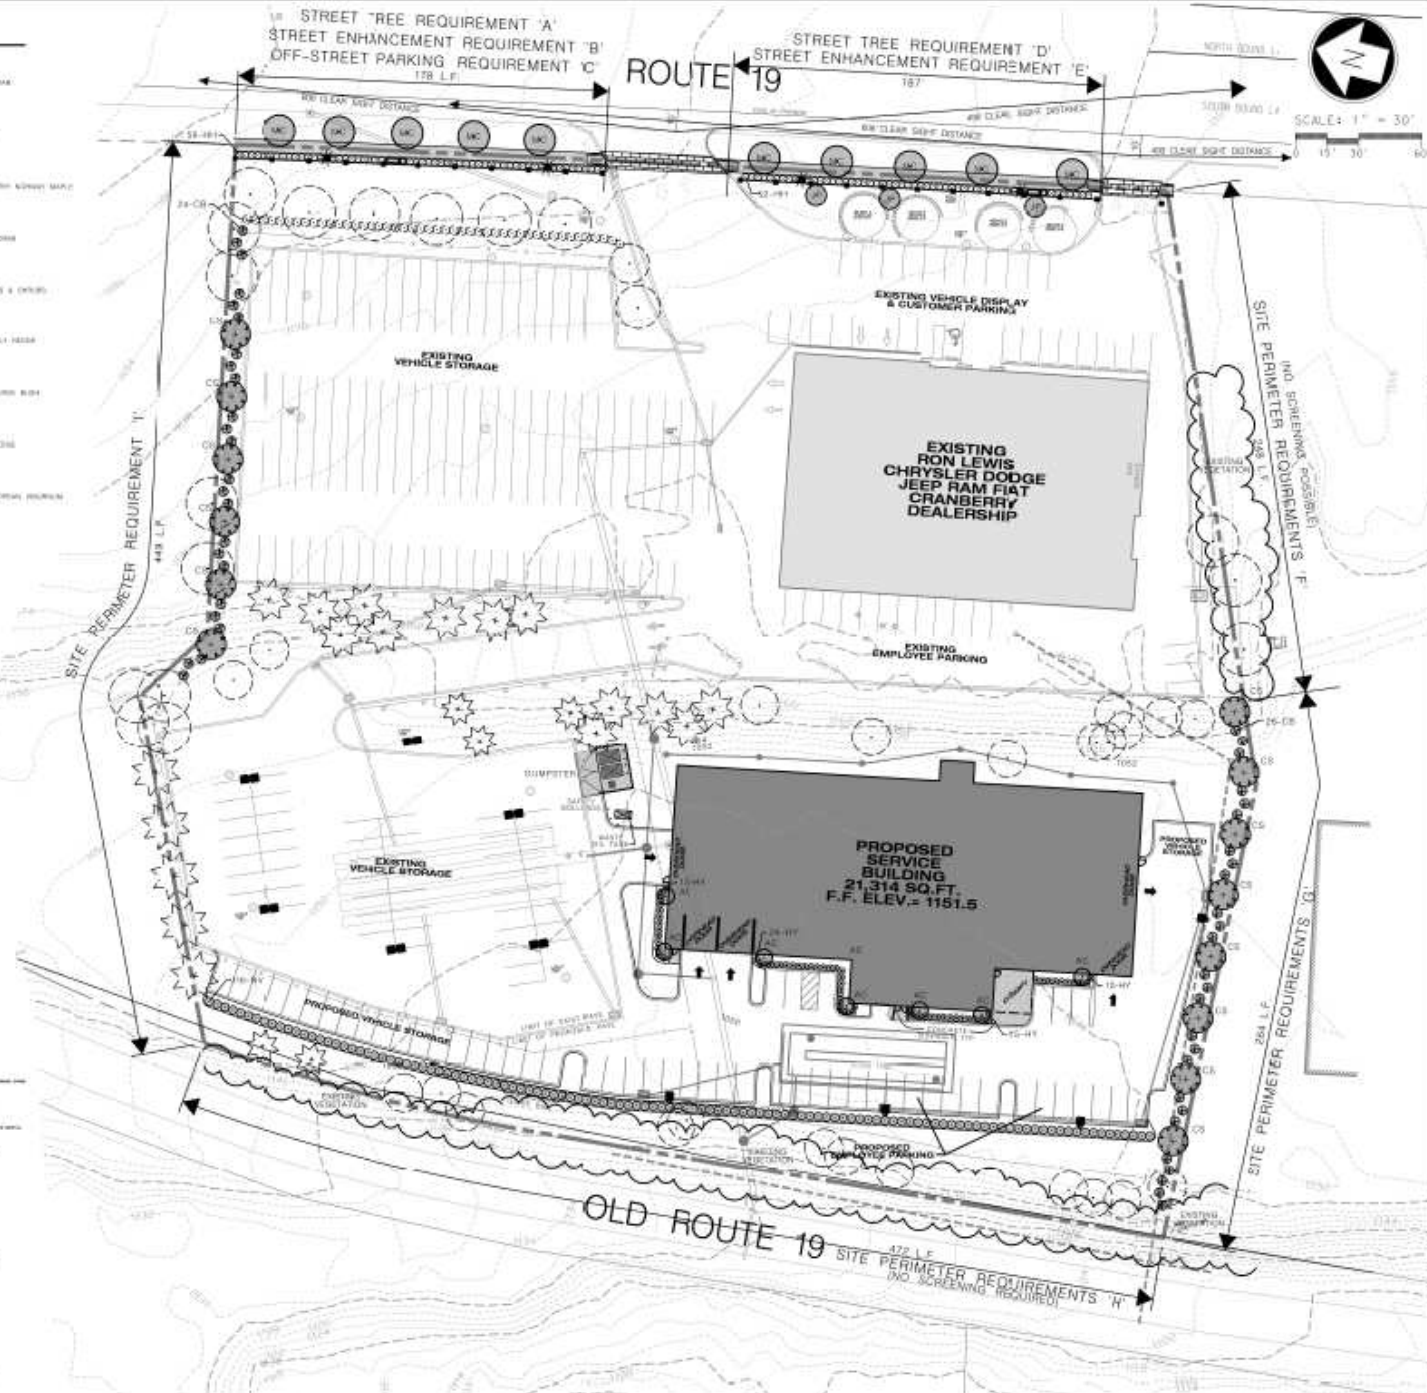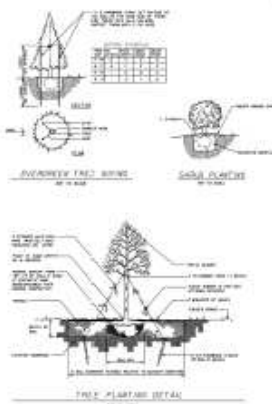[illegible]

418 Second Street
Suite 205
Cambridge, MA 02142
Phone: 617-452-2000
Fax: 617-452-2006
E-mail: info@paulsullivan.com

IRON LEWS SERVICE ADDITION
CRANFORD TOWNSHIP BUTLER COUNTY, PA

LANDSCAPE
PLAN

L-101

SCALE: 0 = Not at all
1 = Somewhat
2 = Quite

LEGEND



PROPOSED CONTOURS



PROPOSED STORM SEWERS



PROPOSED STORM INLETS



PROPOSED CONCRETE ENDWALL




PROPOSED SANITARY SEWER
& MANHOLES



PROPOSED ROCK CHANNEL

GRADING NOTES

1. MINIMUM ALLOWABLE GRADES SHALL BE 1.00% MAXIMUM GRADES SHALL BE 12%.

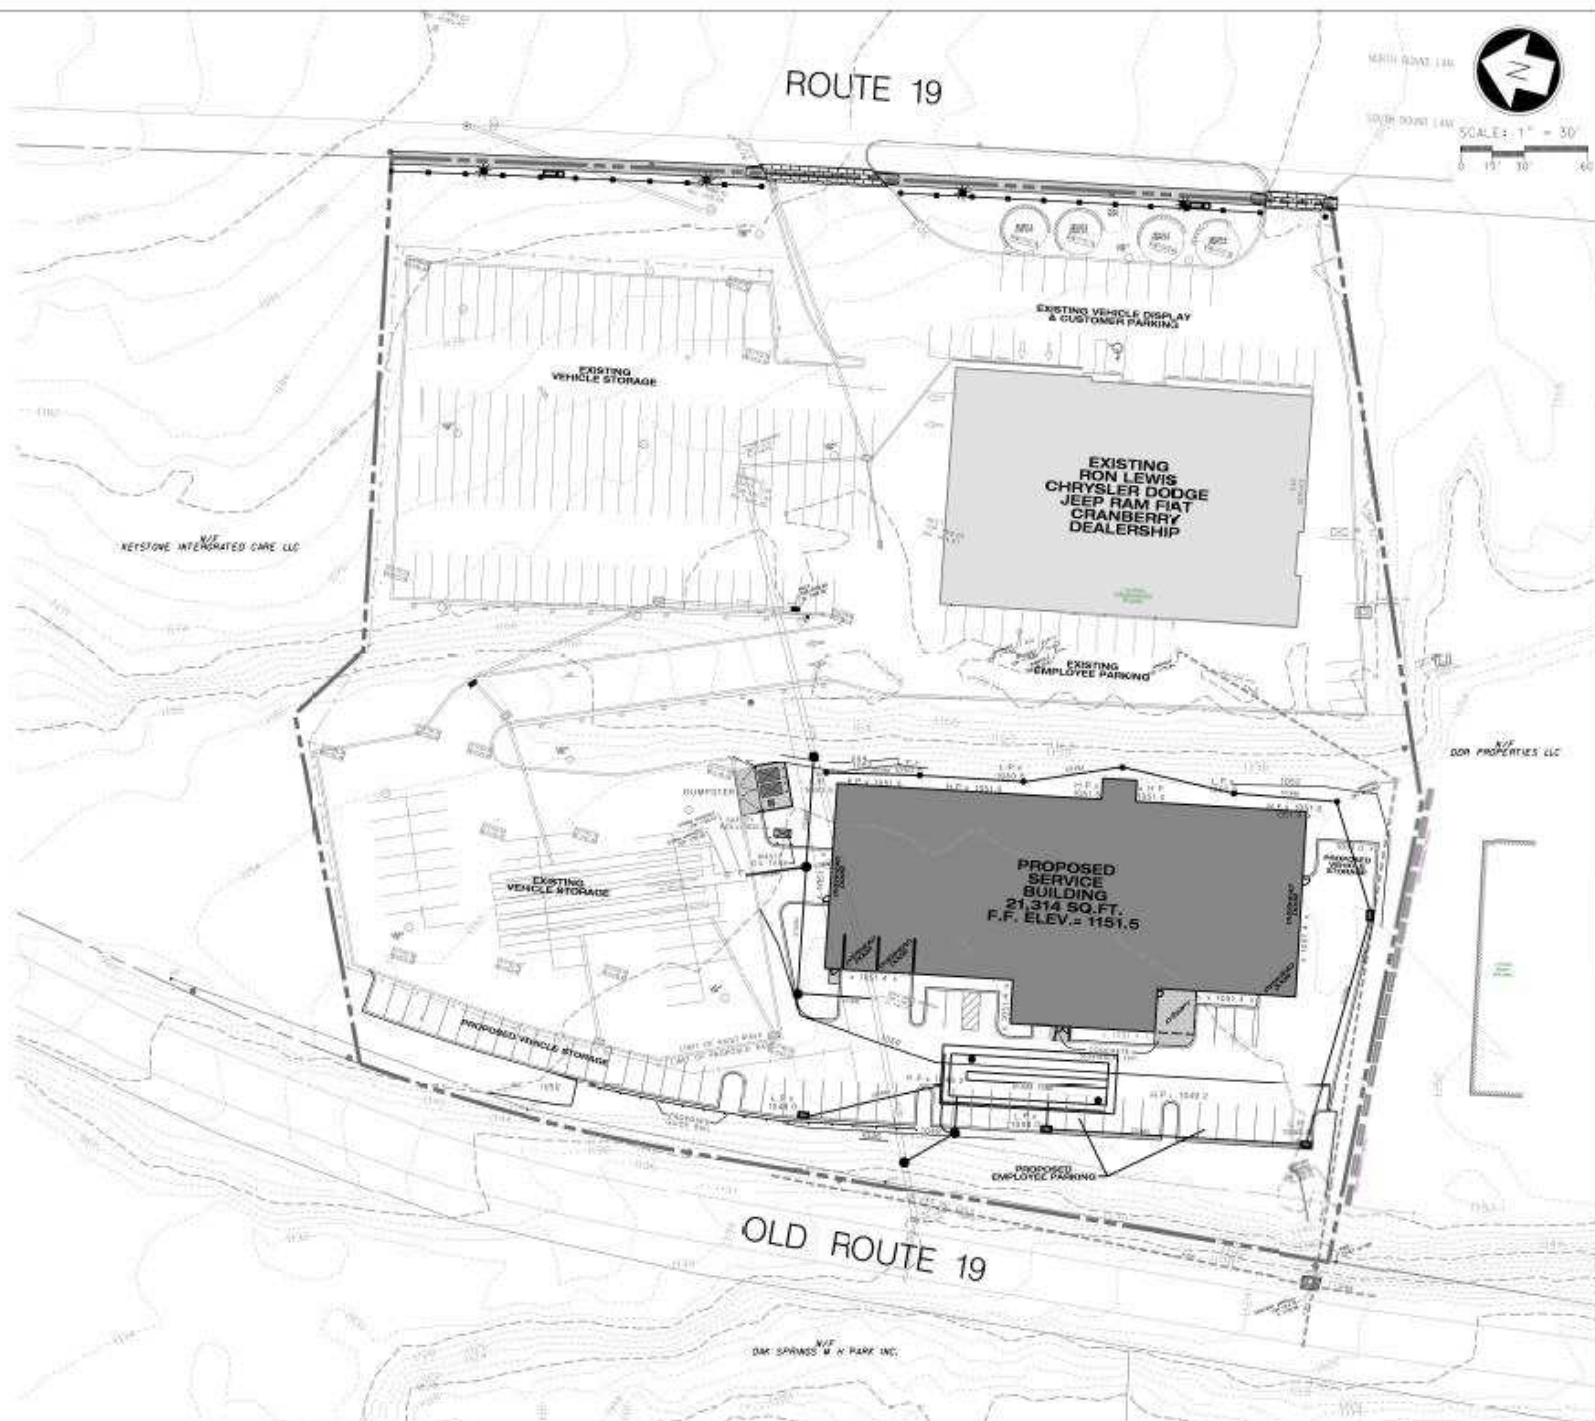

	1980	1981	1982	2432	2
--	------	------	---



University of Michigan Press

[illegible]

FROM LEWIS SERVICE ADDITION


PREPARED FOR
BANKERS BUSINESS INC.
2008 ROUTE 50
CHASSERON, QUEBEC H9B 3G9

GRADING
PLAN
C201

SCALE: 1 = 0% to 100%
 STATE OF WASHINGTON
 JUNE 1997



WEST ELEVATION

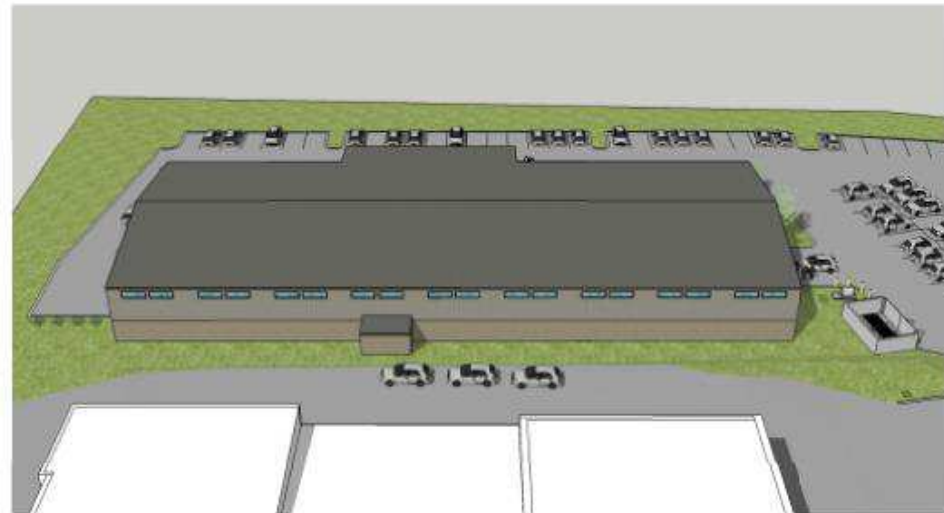

EAST ELEVATION



NORTH ELEVATION



SOUTH ELEVATION



RON LEWIS SERVICE ADDITION
CHANGING TOWNSHIP, BUTLER COUNTY, PA.
DESIGNED BY
ARCHITECTURAL ELEVATIONS
A1

ARCHITECTURAL ELEVATIONS
A1

SCALE: NOT TO SCALE
DATE: 10/10/10
BY: J. L. L.